



KEY

- N1 General Fire Notice
- N2 Staff Fire Notice
- N3 'Fire Door' Sign
- N4 'Fire Exit Keep Clear' sign
- FB Fire Blanket
- FE Fire Extinguisher
- E1 Emergency Light Fitting
- EE Emergency Exit Sign
- S Sensor
- Break Glass Call Point
- Fire Alarm Sounder
- Fire Alarm Panel
- FS Fixed Seating

— Area of current licensable activity and alcohol consumption

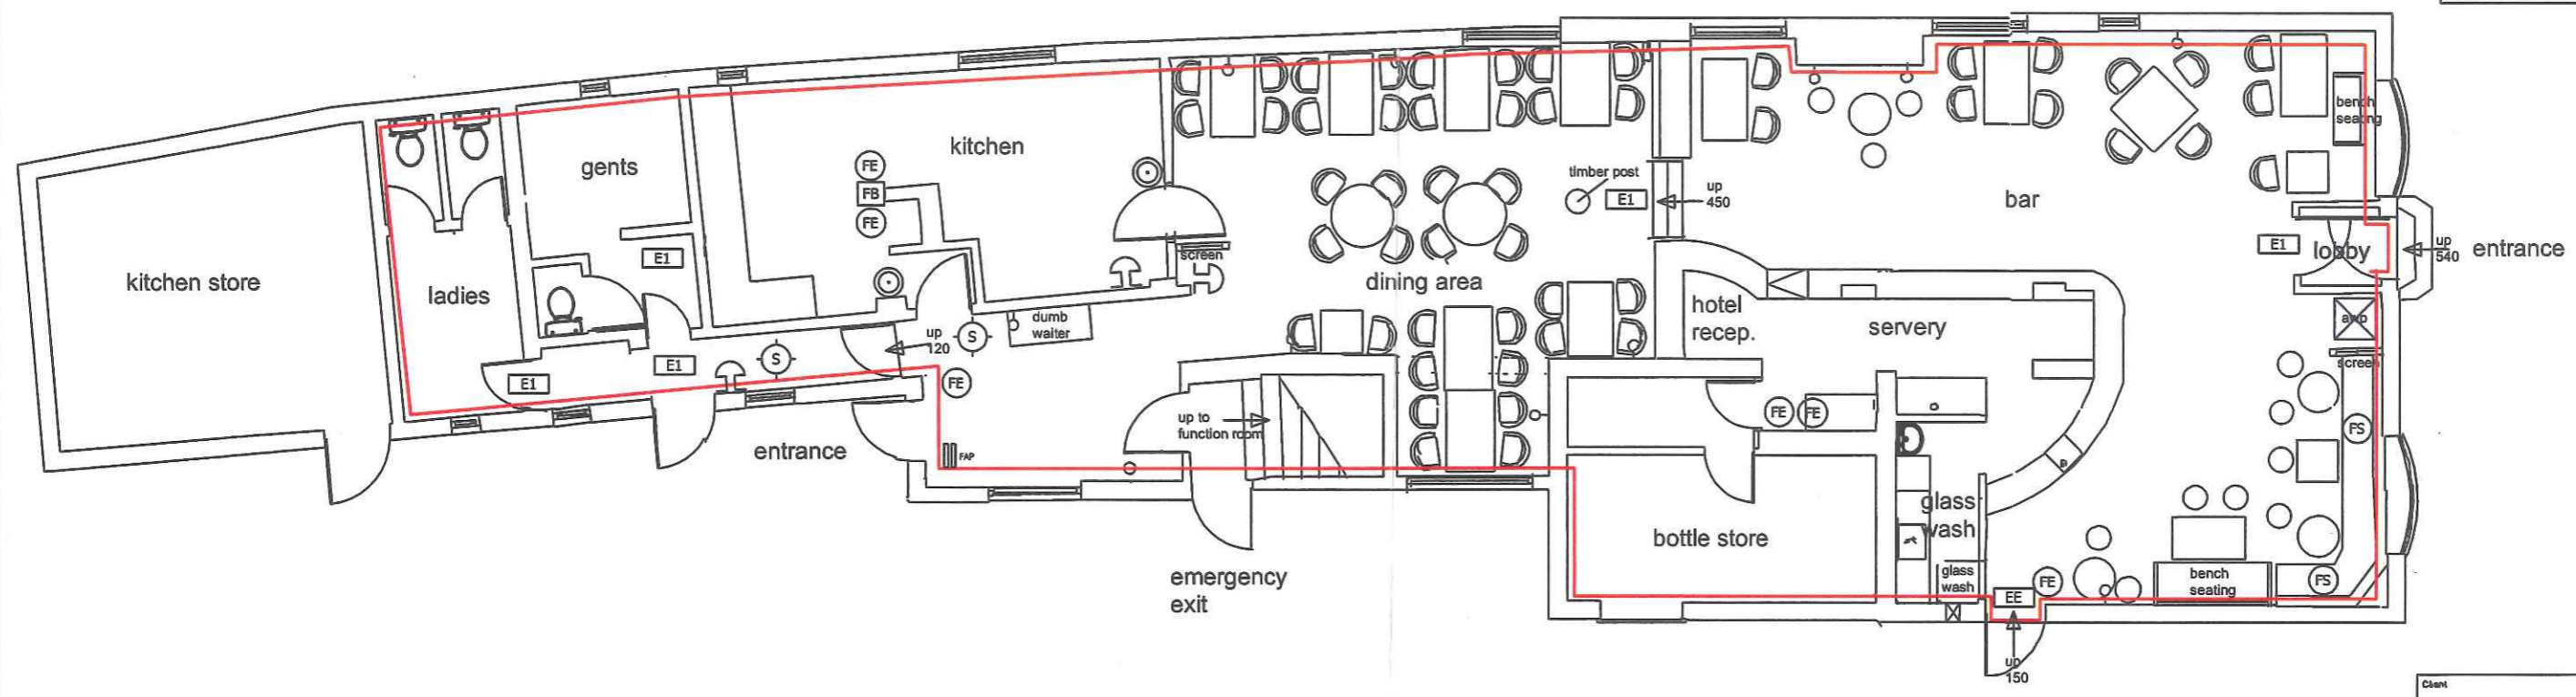

Client	
Everards Brewery Limited	
Job Title	
The Falcon Main Street Long Whatton Loughborough LE12 5DG	
Drawing Title	
Ground Floor Plan	
Scale	
1 : 100	
Date	
May '99	
Drawn by	Rev
F722 / 21	

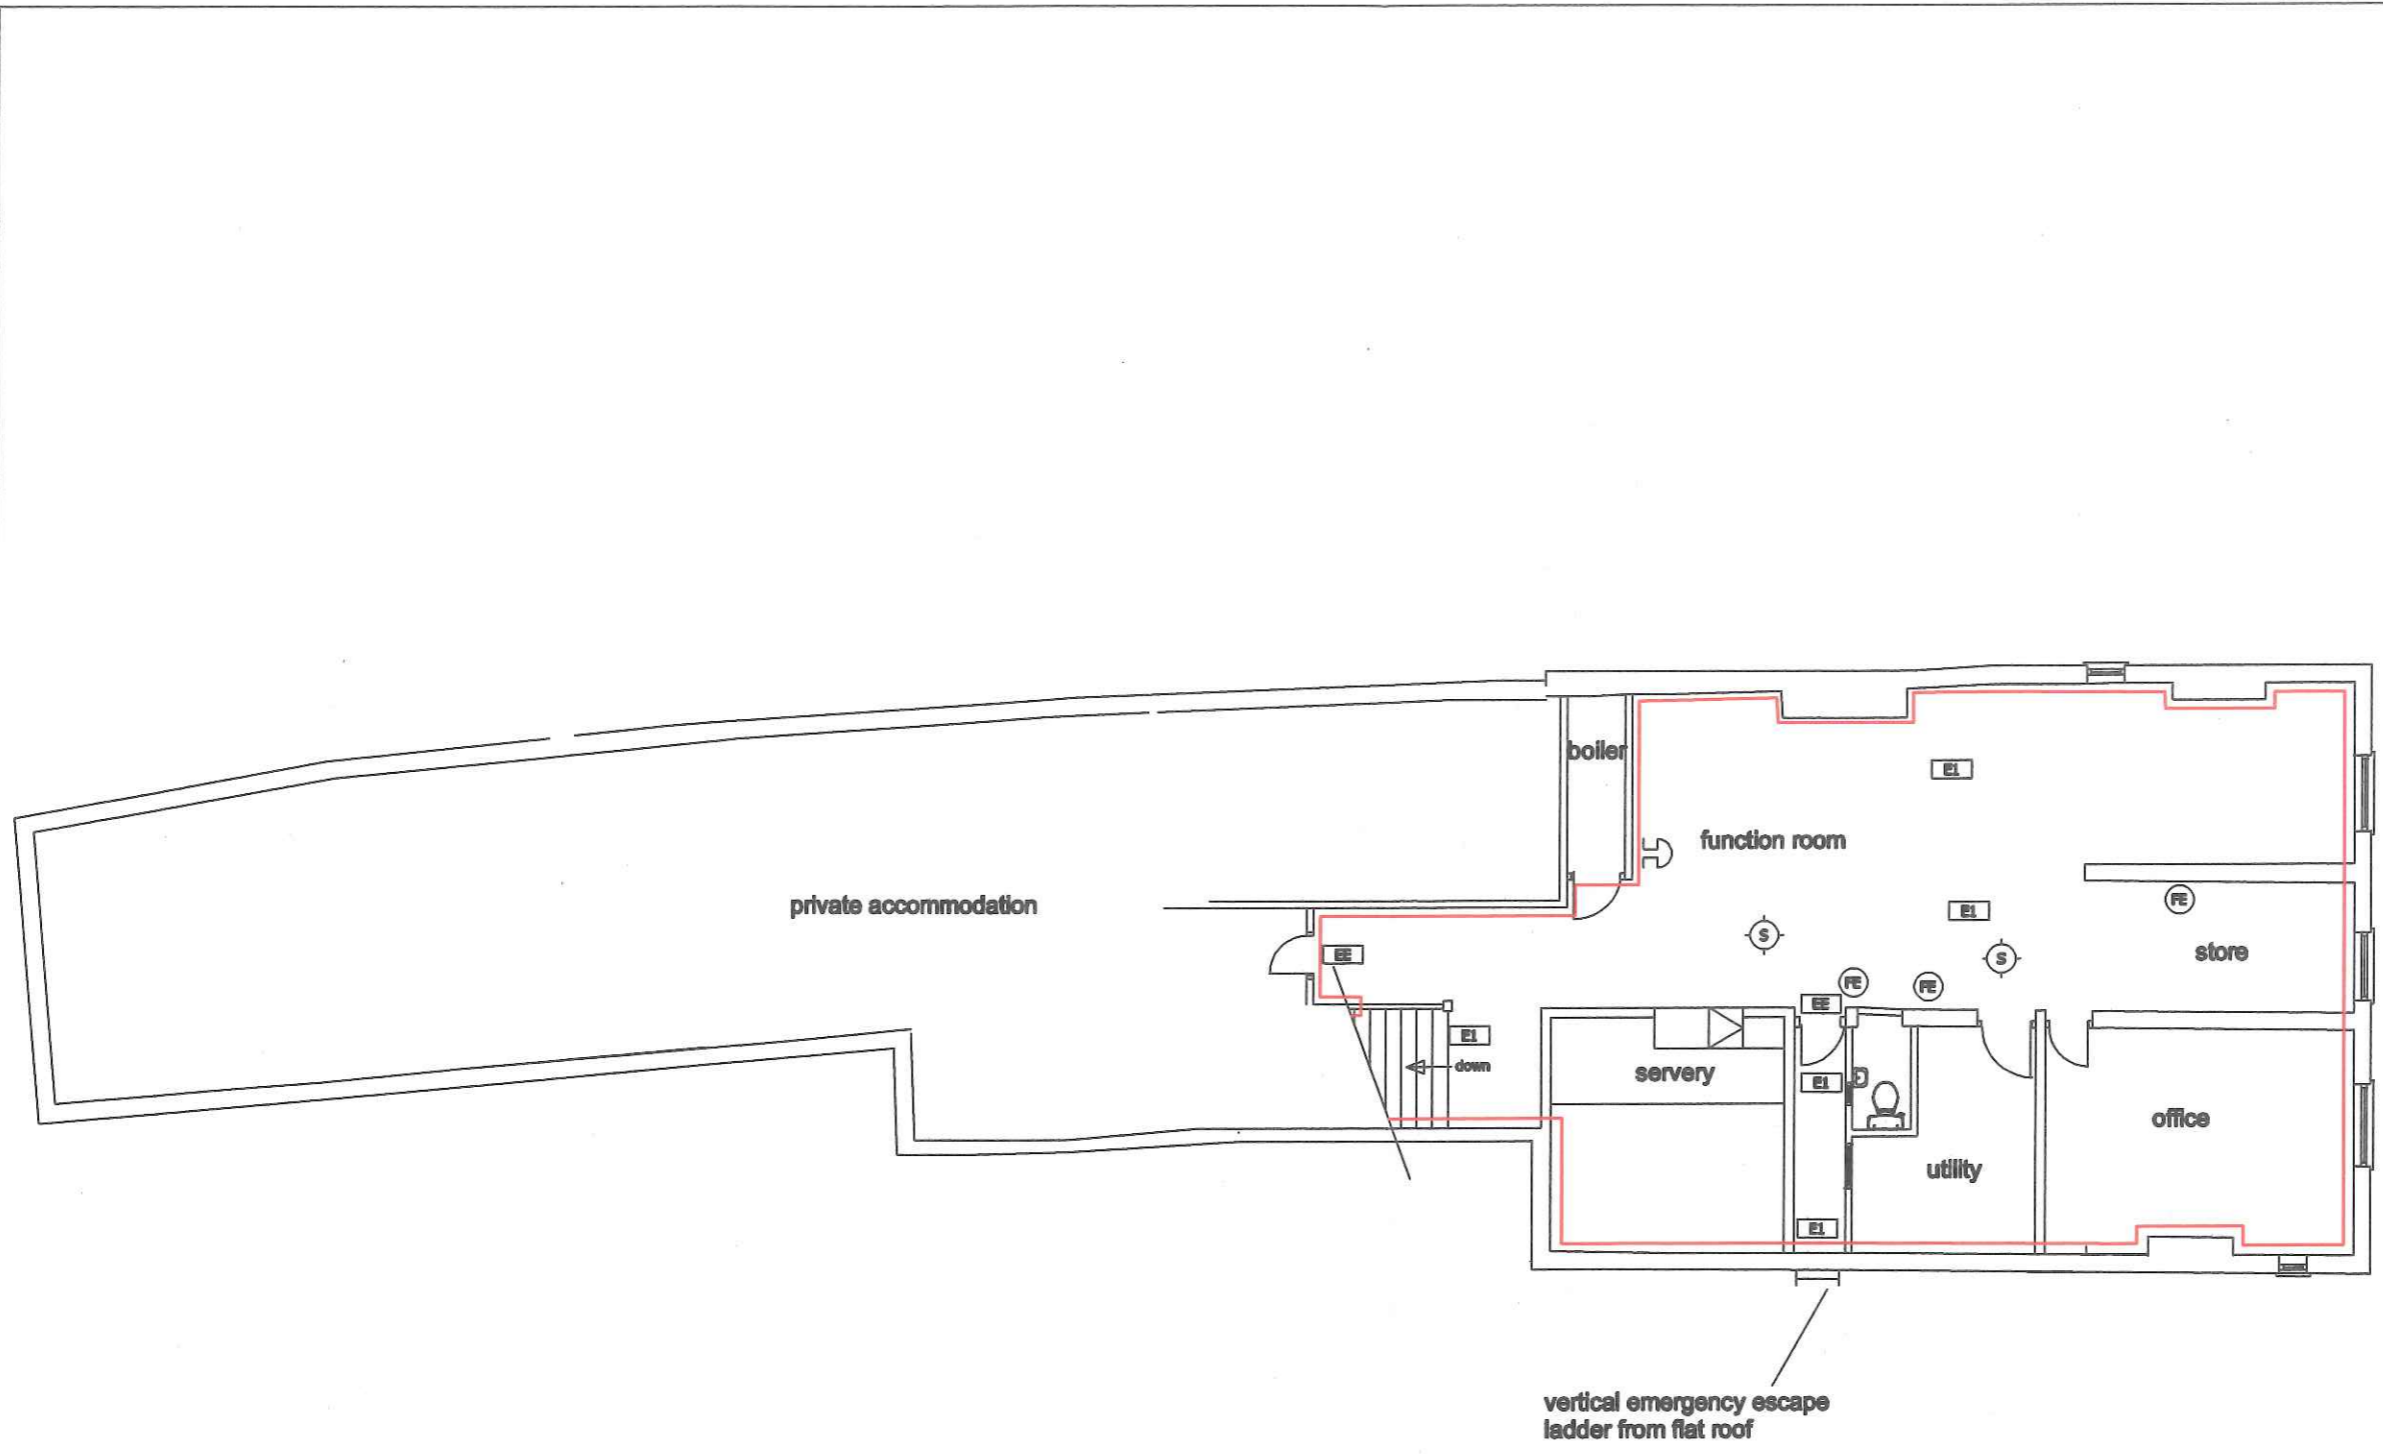

Services Key	
EM	Electricity Meter
GM	Gas Meter
WM	Water Meter
[Symbol]	Mains Distribution Board
FP	Fire Place (open fire)
FPR	Fire Place (redundant)
FPG	Fire Place (gas)
FPE	Fire Place (electric)
[Symbol]	Extract Fan
[Symbol]	ceiling fan
[Symbol]	Gas Isolation Valve
[Symbol]	Mains Water Isolation Valve

KEY	
N1	General Fire Notice
N2	Staff Fire Notice
N3	Fire Door Sign
N4	'Fire Exit Keep Clear' sign
FB	Fire Blanket
FE	Fire Extinguisher
EI	Emergency Light Fitting
EE	Emergency Exit Sign
S	Sensor
[Symbol]	Break Glass Call Point
[Symbol]	Fire Alarm Sounder
[Symbol]	Fire Alarm Panel
FS	Fixed Seating
[Red Line]	Area of current licensable activity and alcohol consumption

Client	Everards Brewery Limited
Job Title	The Falcon Main Street Long Whaddon Loughborough LE12 5DG
Drawing Title	First Floor Plan
Scale	1 : 100
Date	DEC 2019
By	
Rev	
By ref.	F722 / 21

Nov 2019